



**ISSUED**  
 APR 20 2001  
 HECKY GROUP

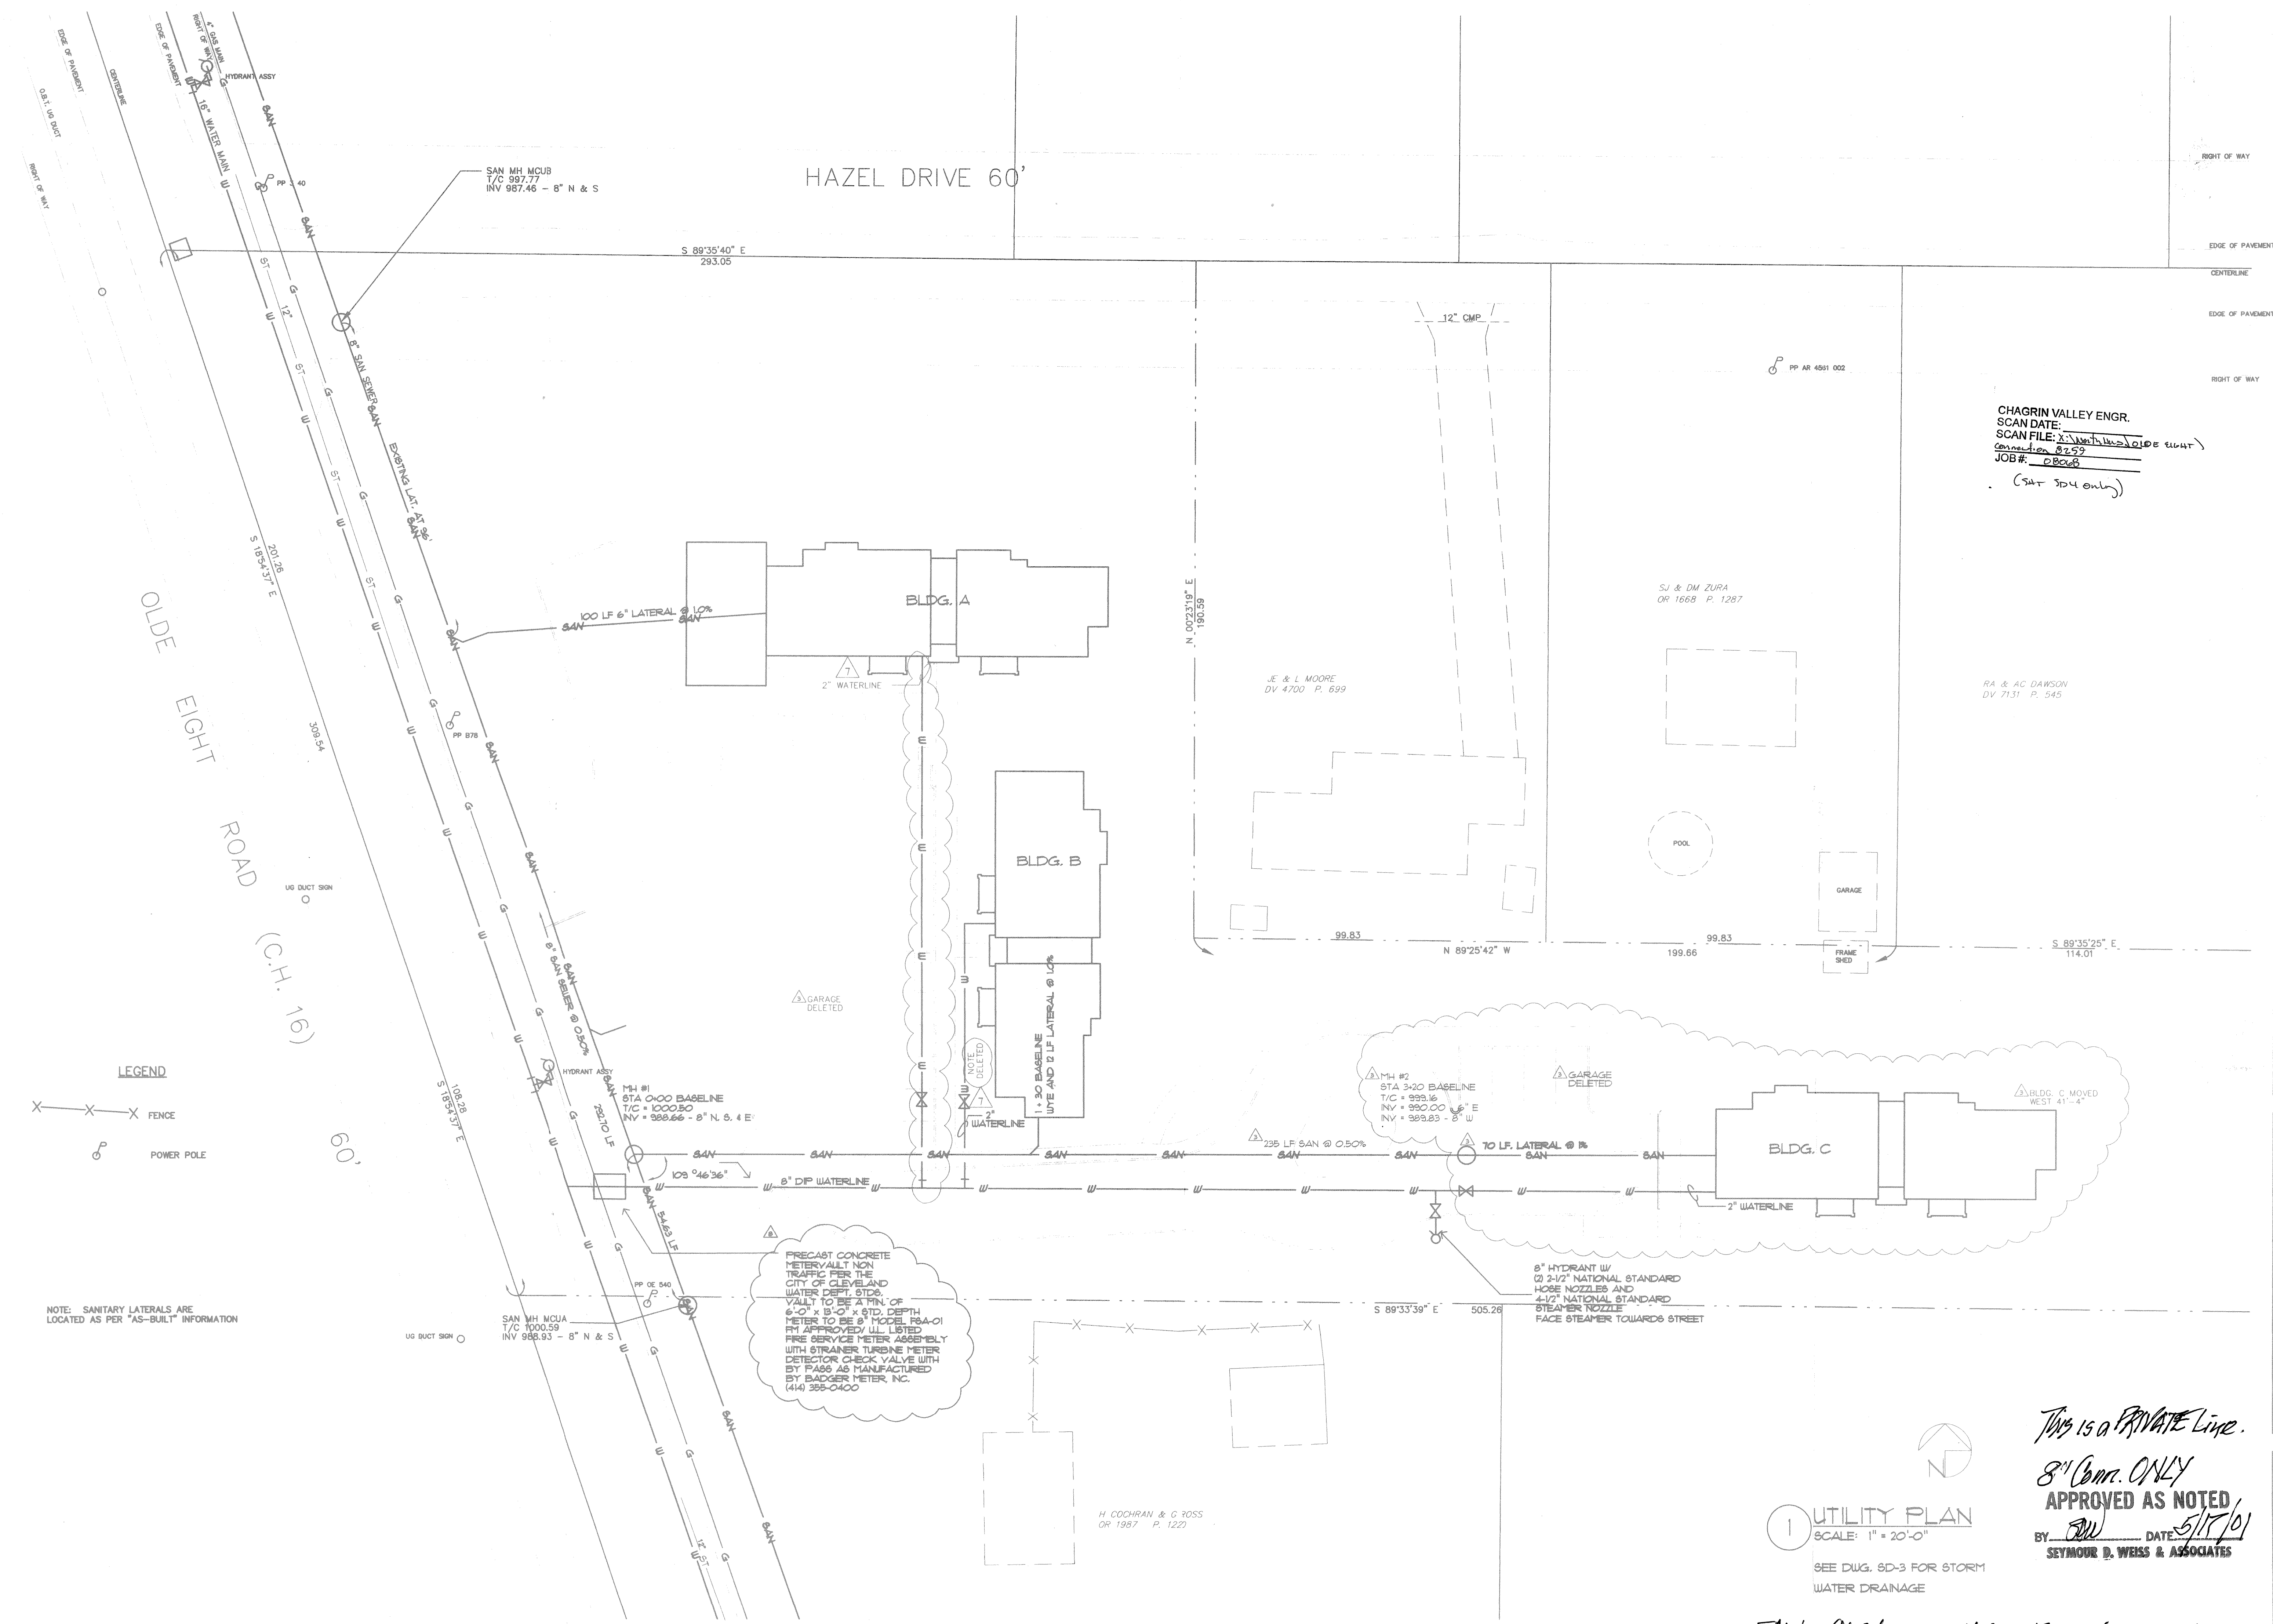

CHAGRIN VALLEY ENGR.  
 SCAN DATE: 3/21/01  
 SCAN FILE: X:\with\1041\01041-592.dwg  
 connection 8.2.59  
 JOB #: 08008  
 (SAY 5/17/01 ONLY)

REV	DATE	DESCRIPTION
1	3/21/01	8-1700 Issues For Construction
2	10-11-00	3-5-01 Water Dept. Comments
3	3-21-01	

Architecture Planning Interior Design  
 2525 Second Street  
 Cuyahoga Falls, Ohio 44221  
 330-928-6688  
 Fax: 330-928-8259

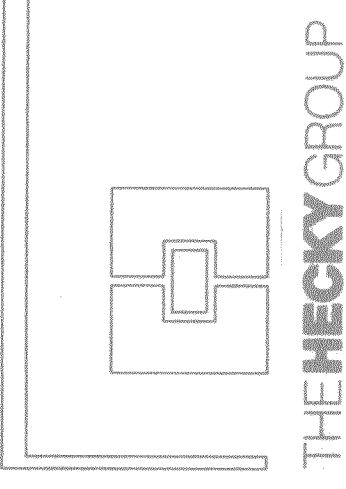

Utility Plan  
 drawing  
 H.M. Life  
 Opportunity Services  
 project

date	3/21/01
project number	2798
sheet	SD-4

*This is a PRIVATE Line.*  
 8" Conn. ONLY  
**APPROVED AS NOTED**  
 BY *SW* DATE *5/17/01*  
 SEYMOUR D. WEISS & ASSOCIATES

**UTILITY PLAN**  
 SCALE: 1" = 20'-0"  
 SEE DIAG. SD-3 FOR STORM WATER DRAINAGE

JWA COPY

NHWDD PROJ #: 0104.1-592

H. COCHRAN & G. ROSS  
 OR 1957 P. 1222

PRECAST CONCRETE METERYAULT NON TRAFFIC PER THE CITY OF CLEVELAND WATER DEPT. STD. VAULT TO BE A MIN. OF 6'-0" X 8'-0" X STD. DEPTH METER TO BE 8" MODEL P84-01 FM APPROVED/UL LISTED FIRE SERVICE METER ASSEMBLY WITH STRAINER TURBINE METER DETECTOR CHECK VALVE WITH BY PASS AS MANUFACTURED BY BADGER METER, INC. (414) 358-0400

**LEGEND**  
 X X X FENCE  
 P POWER POLE

NOTE: SANITARY LATERALS ARE LOCATED AS PER "AS-BUILT" INFORMATION